

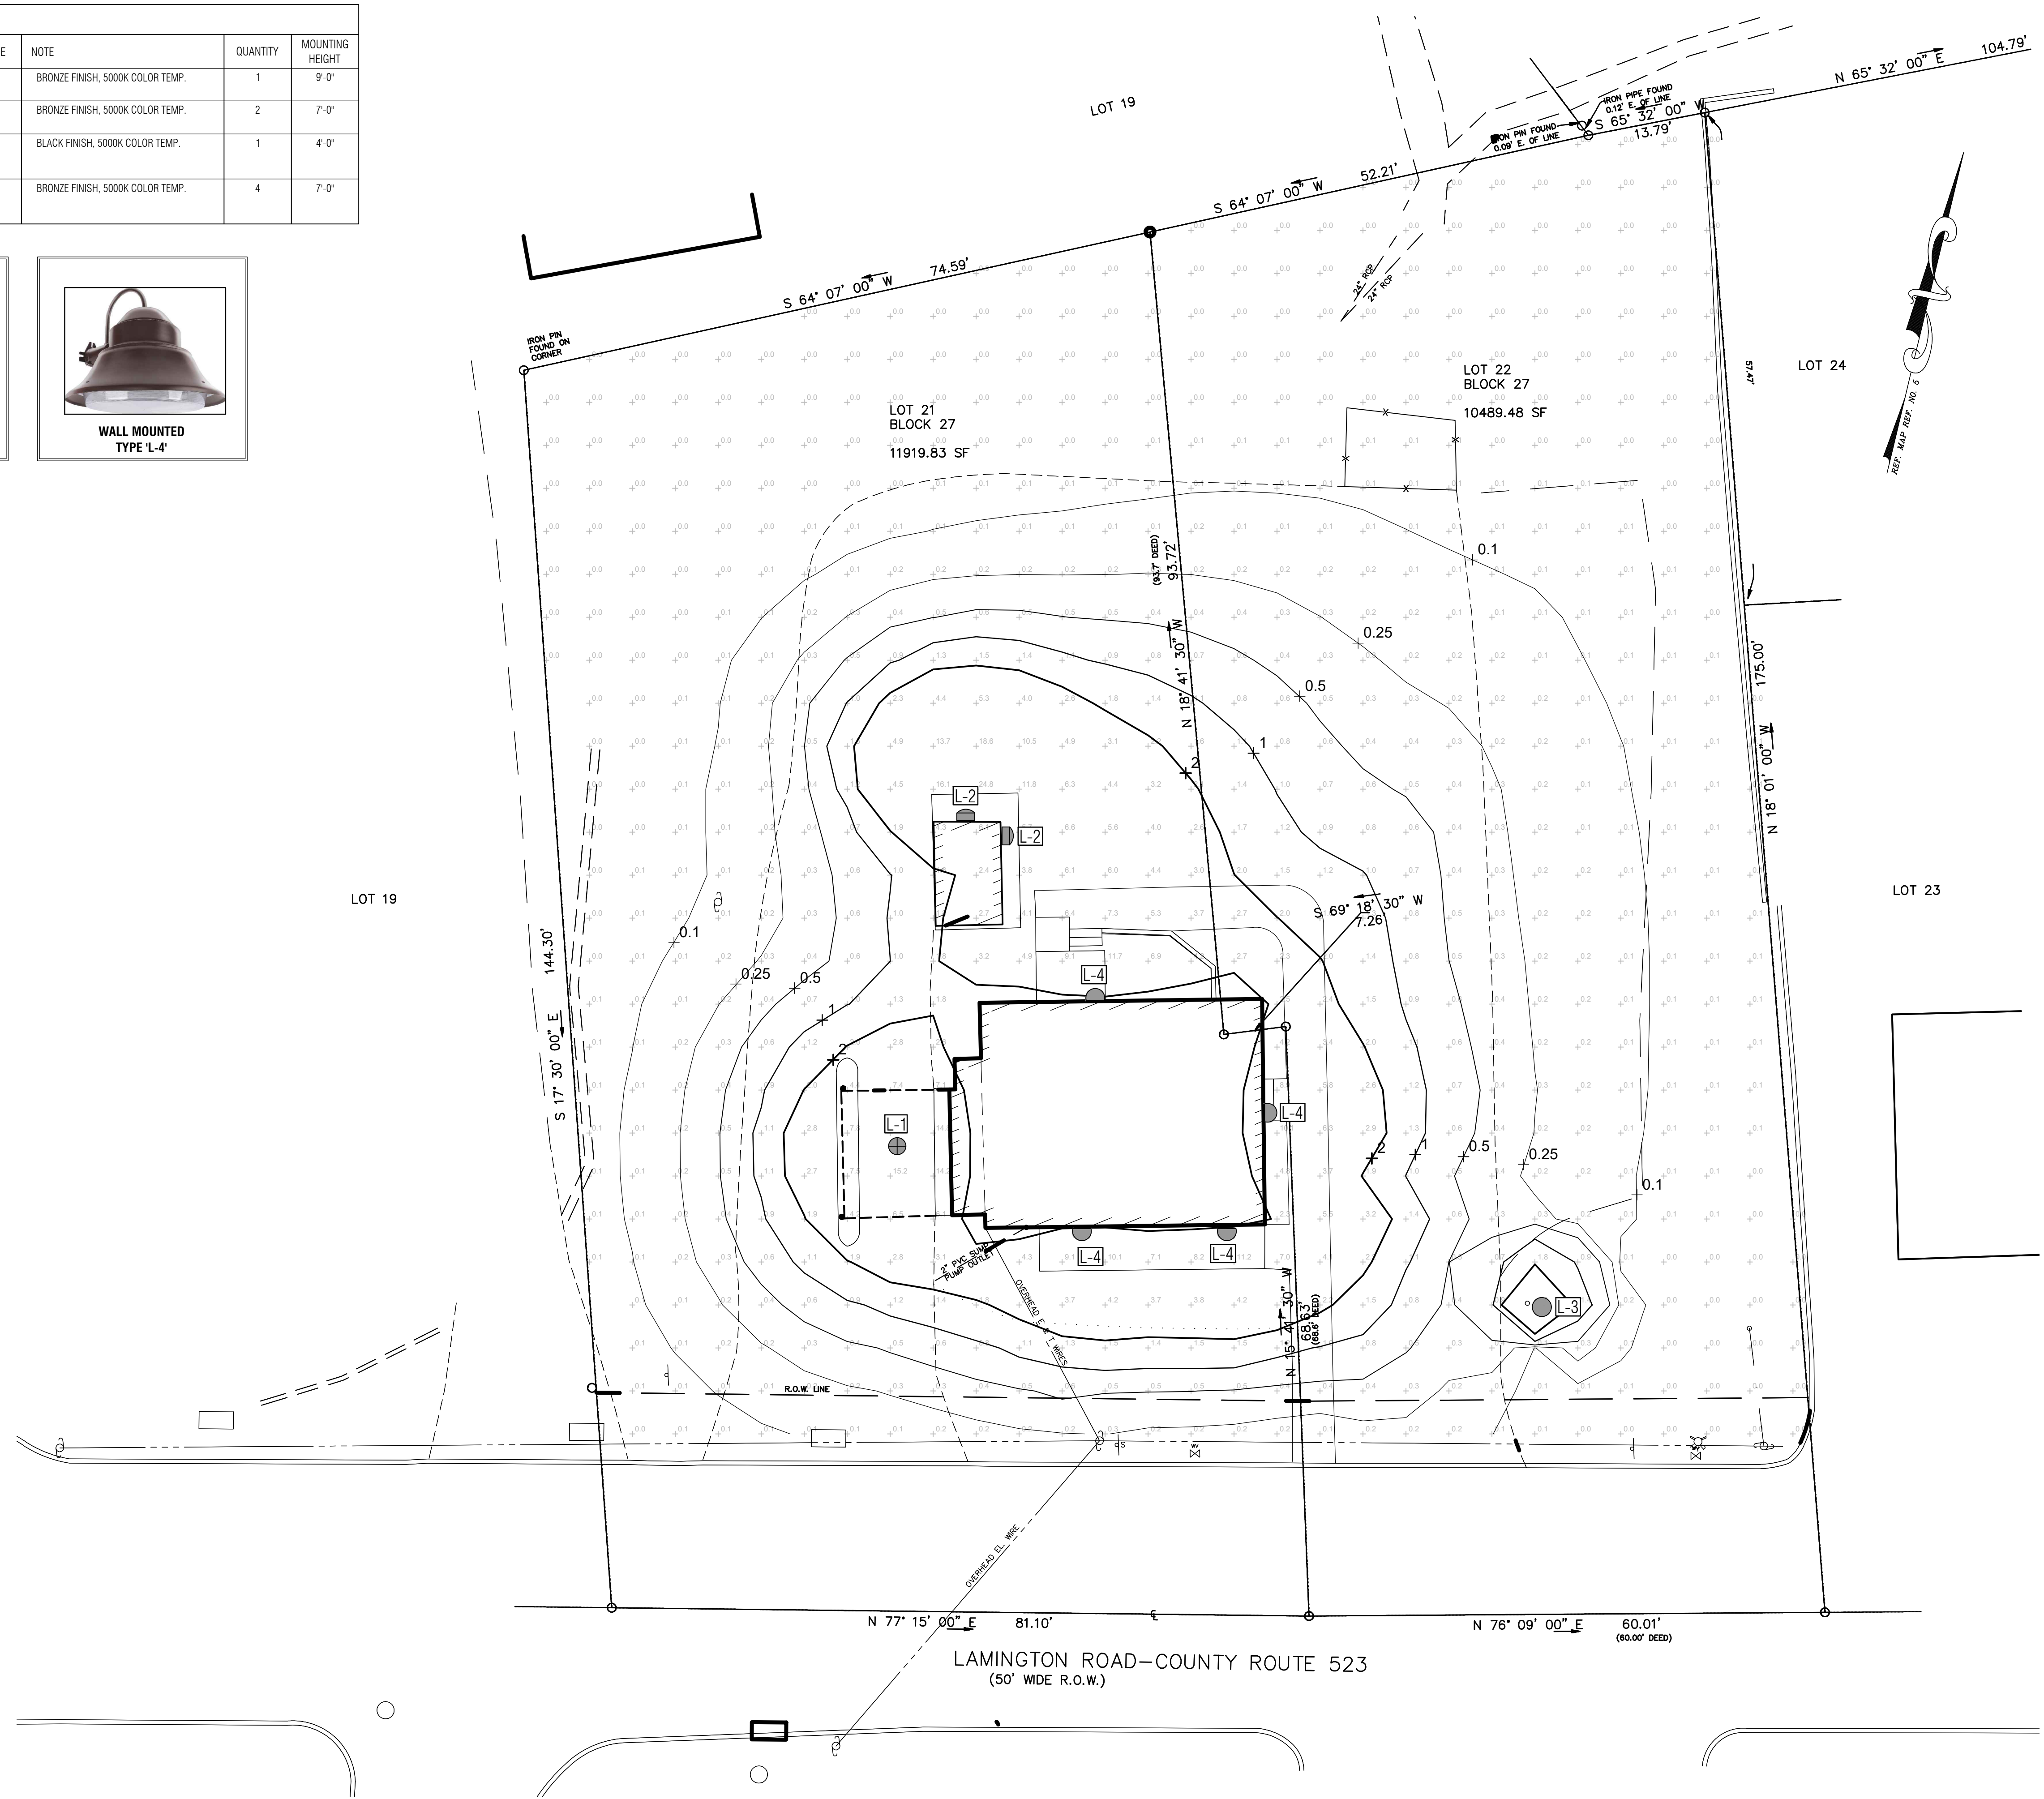
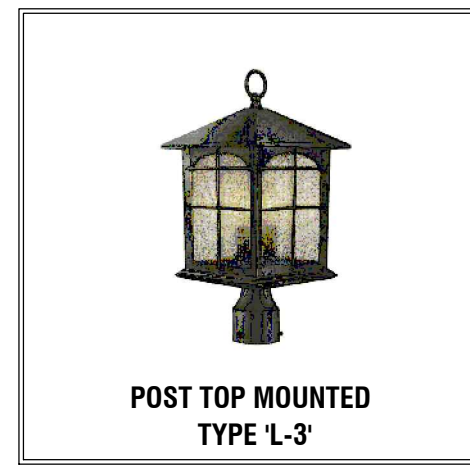


PROPOSED LUMINAIRE SCHEDULE								
SYMBOL	LABEL	DESCRIPTION	MANUFACTURER	MODEL	WATTAGE	NOTE	QUANTITY	MOUNTING HEIGHT
⊕	L-1	SURFACE MOUNTED LIGHT (CANOPY)	VIRIBRIGHT	40-WATT CANOPY SQUARE FIXTURE	40	BRONZE FINISH, 5000K COLOR TEMP.	1	9'-0"
▭	L-2	AREA LIGHT, WALL MOUNTED	LITHONIA	ARC2LED P4 50K	30	BRONZE FINISH, 5000K COLOR TEMP.	2	7'-0"
●	L-3	POST LIGHT	PHILIPS	BRIMFIELD	5	BLACK FINISH, 5000K COLOR TEMP.	1	4'-0"
▭	L-4	WALL MOUNTED	FEIT ELECTRIC	73700	50	BRONZE FINISH, 5000K COLOR TEMP.	4	7'-0"

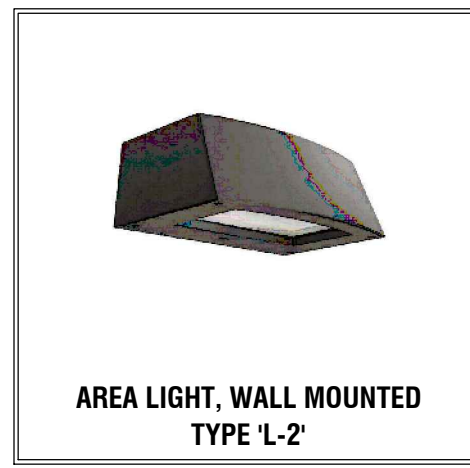

**Inglese Architecture + Engineering**

632 Pompton Avenue  
Cedar Grove, NJ 07009  
t. 201.438.0081  
www.inglese-ae.com  
info@inglese-ae.com

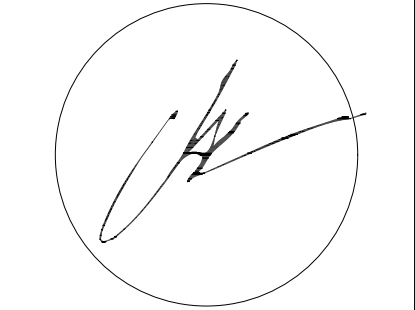

JOHN INGLESE NJ A00946900  
JOAQUIN BOLZAS NJ A02099700  
ALEXANDER MERLUCCI NJ A00202700  
ANTHONY DRAGOSTA III NJ A02023700

THIS DOCUMENT IS THE EXCLUSIVE PROPERTY OF INGLESE ARCHITECTURE + ENGINEERING. THE DOCUMENT AND THE INFORMATION IT CONTAINS MAY NOT BE REPRODUCED OR USED FOR OTHER THAN THE SPECIFIC PROJECT FOR WHICH IT WAS PREPARED WITHOUT THE EXPLICIT CONSENT OF INGLESE ARCHITECTURE + ENGINEERING.

CONSULTANTS:

**2475 LAMINGTON ROAD**  
BEDMINSTER TOWNSHIP  
BLOCK: 27 LOT: 21 & 22


SUBMISSIONS:  
VARIANCE PLAN 10.31.2023

REVISIONS:

IAE PROJECT NO: 23000

SHEET TITLE:  
LIGHTING SITE PLAN

SHEET:  
**C-1.50**

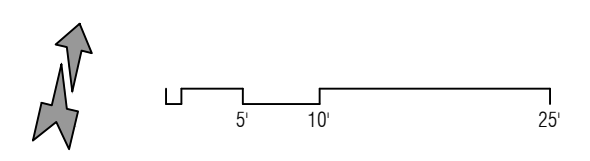

**1 LIGHTING SITE PLAN**  
SCALE: 1" = 10'

DATE PLOTTED: 10/31/2023 10:31:23 AM PROJECT: 23000 SHEET: C-1.50